



2/17/2023 8:10 AM JOB NUMBER 2020 20032 - Dunham Public Library PHASE III Schematic Plans Phase III 2nd Flr Plan.dwg

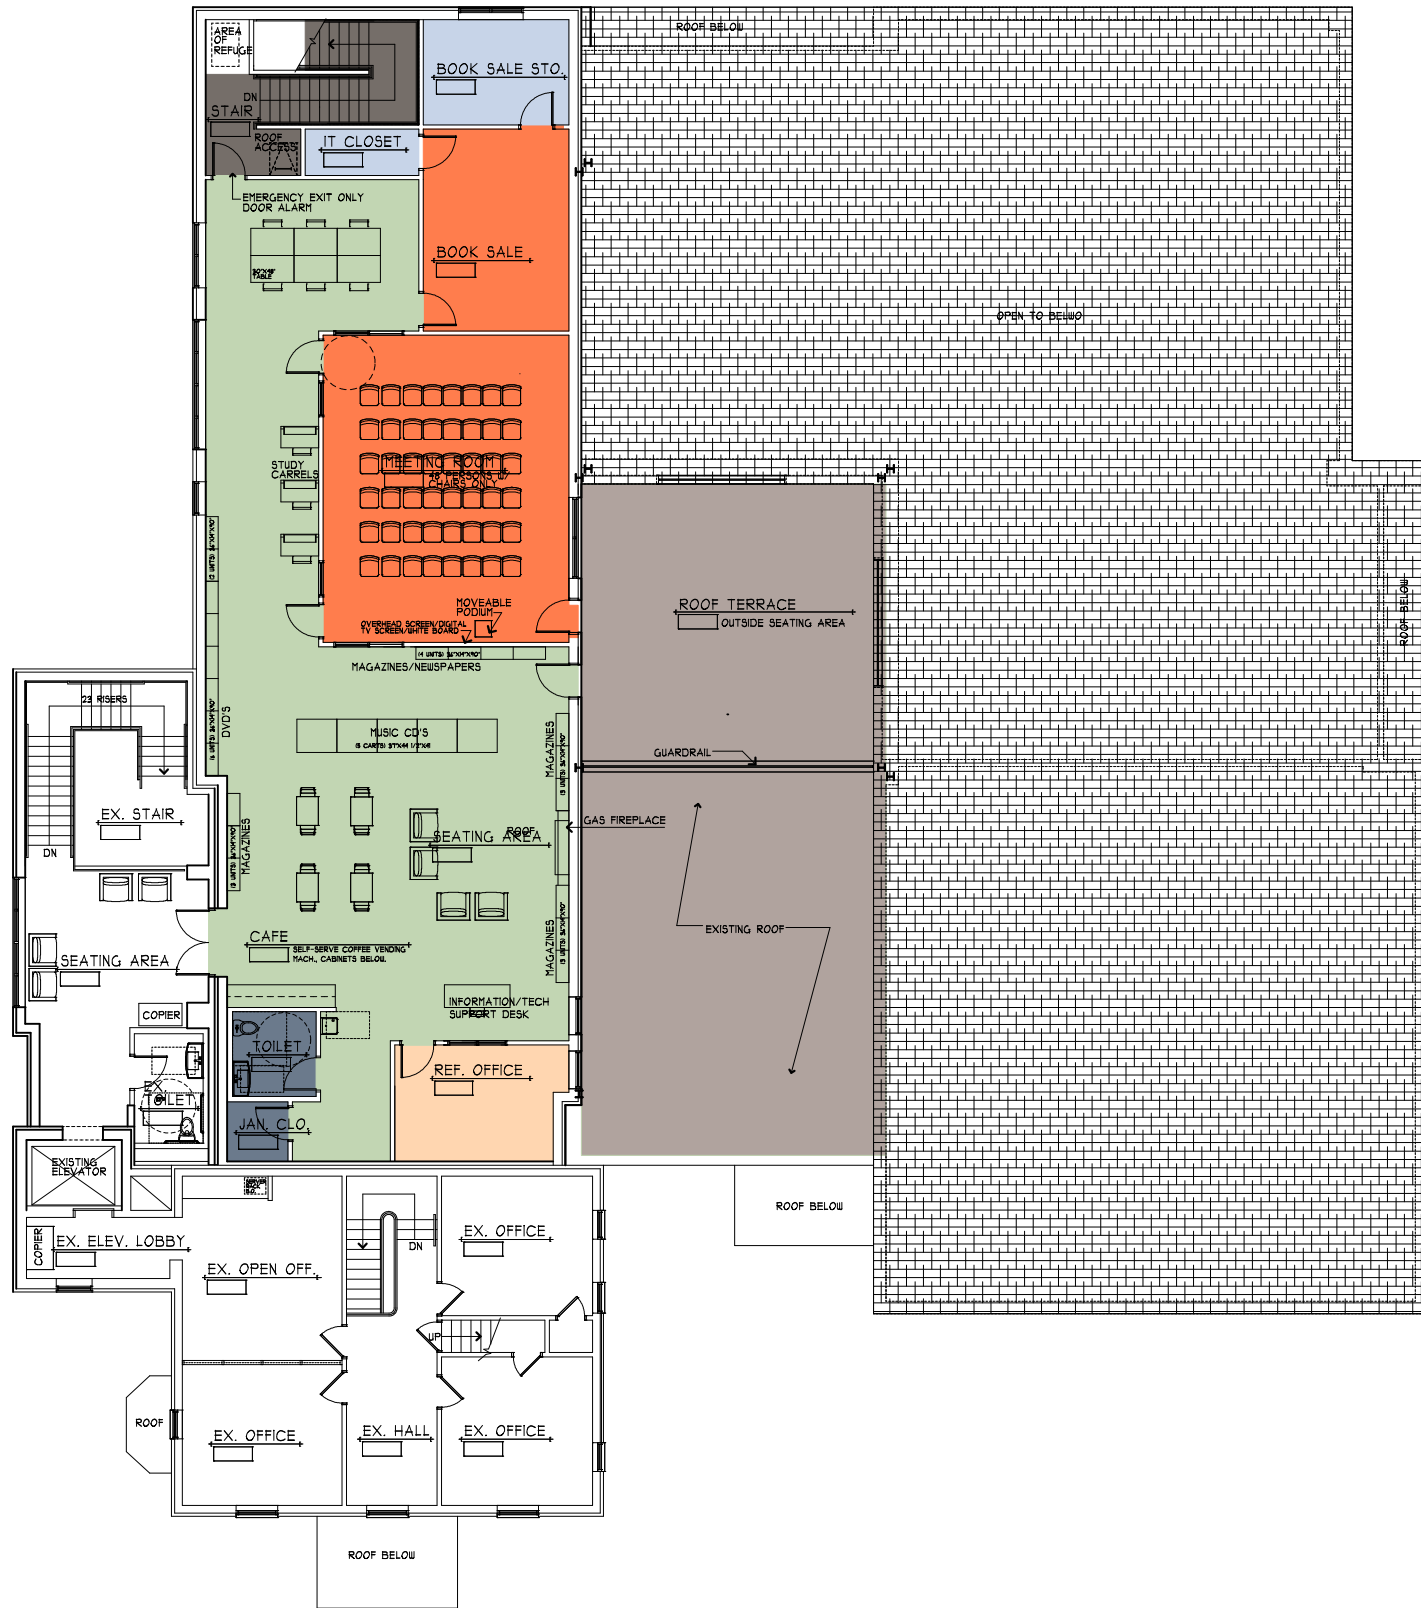

SCHEMATIC SECOND FLOOR PLAN

SCALE: 1/8" = 1'-0"

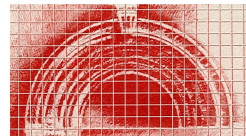

HOLMES ■ KING ■ KALLQUIST
& Associates, Architects, LLP

575 NORTH SALINA STREET ■ SYRACUSE, N.Y. 13208

315.476.8371

www.hkkarchitects.com

315.476.5420 FAX

PHASE III SCHEMATIC PLANS
DUNHAM PUBLIC LIBRARY

FEBRUARY 17, 2023

76 MAIN STREET, WHITESBORO, NEW YORK 13492